



T.F. CUSANELLI & FILLETTI
ARCHITECTS, P.C.





PROPOSED:
SINGLE FAMILY RESIDENCE
353 TRENSCH SRIVE
NEW MILFORD, NJ 07646

REVISIONS		
NO.	DESCRIPTION	DATE

DWG. TITLE:
FIRST FLOOR PLAN

DWG. NO.
A-4

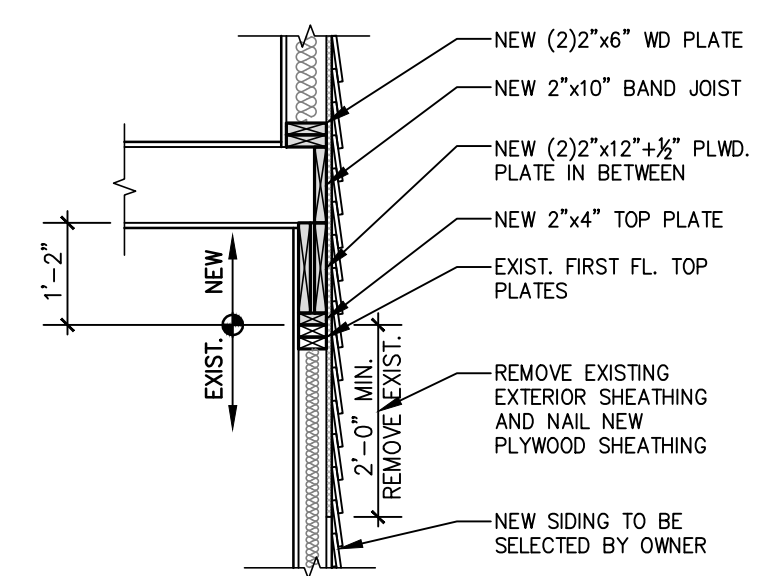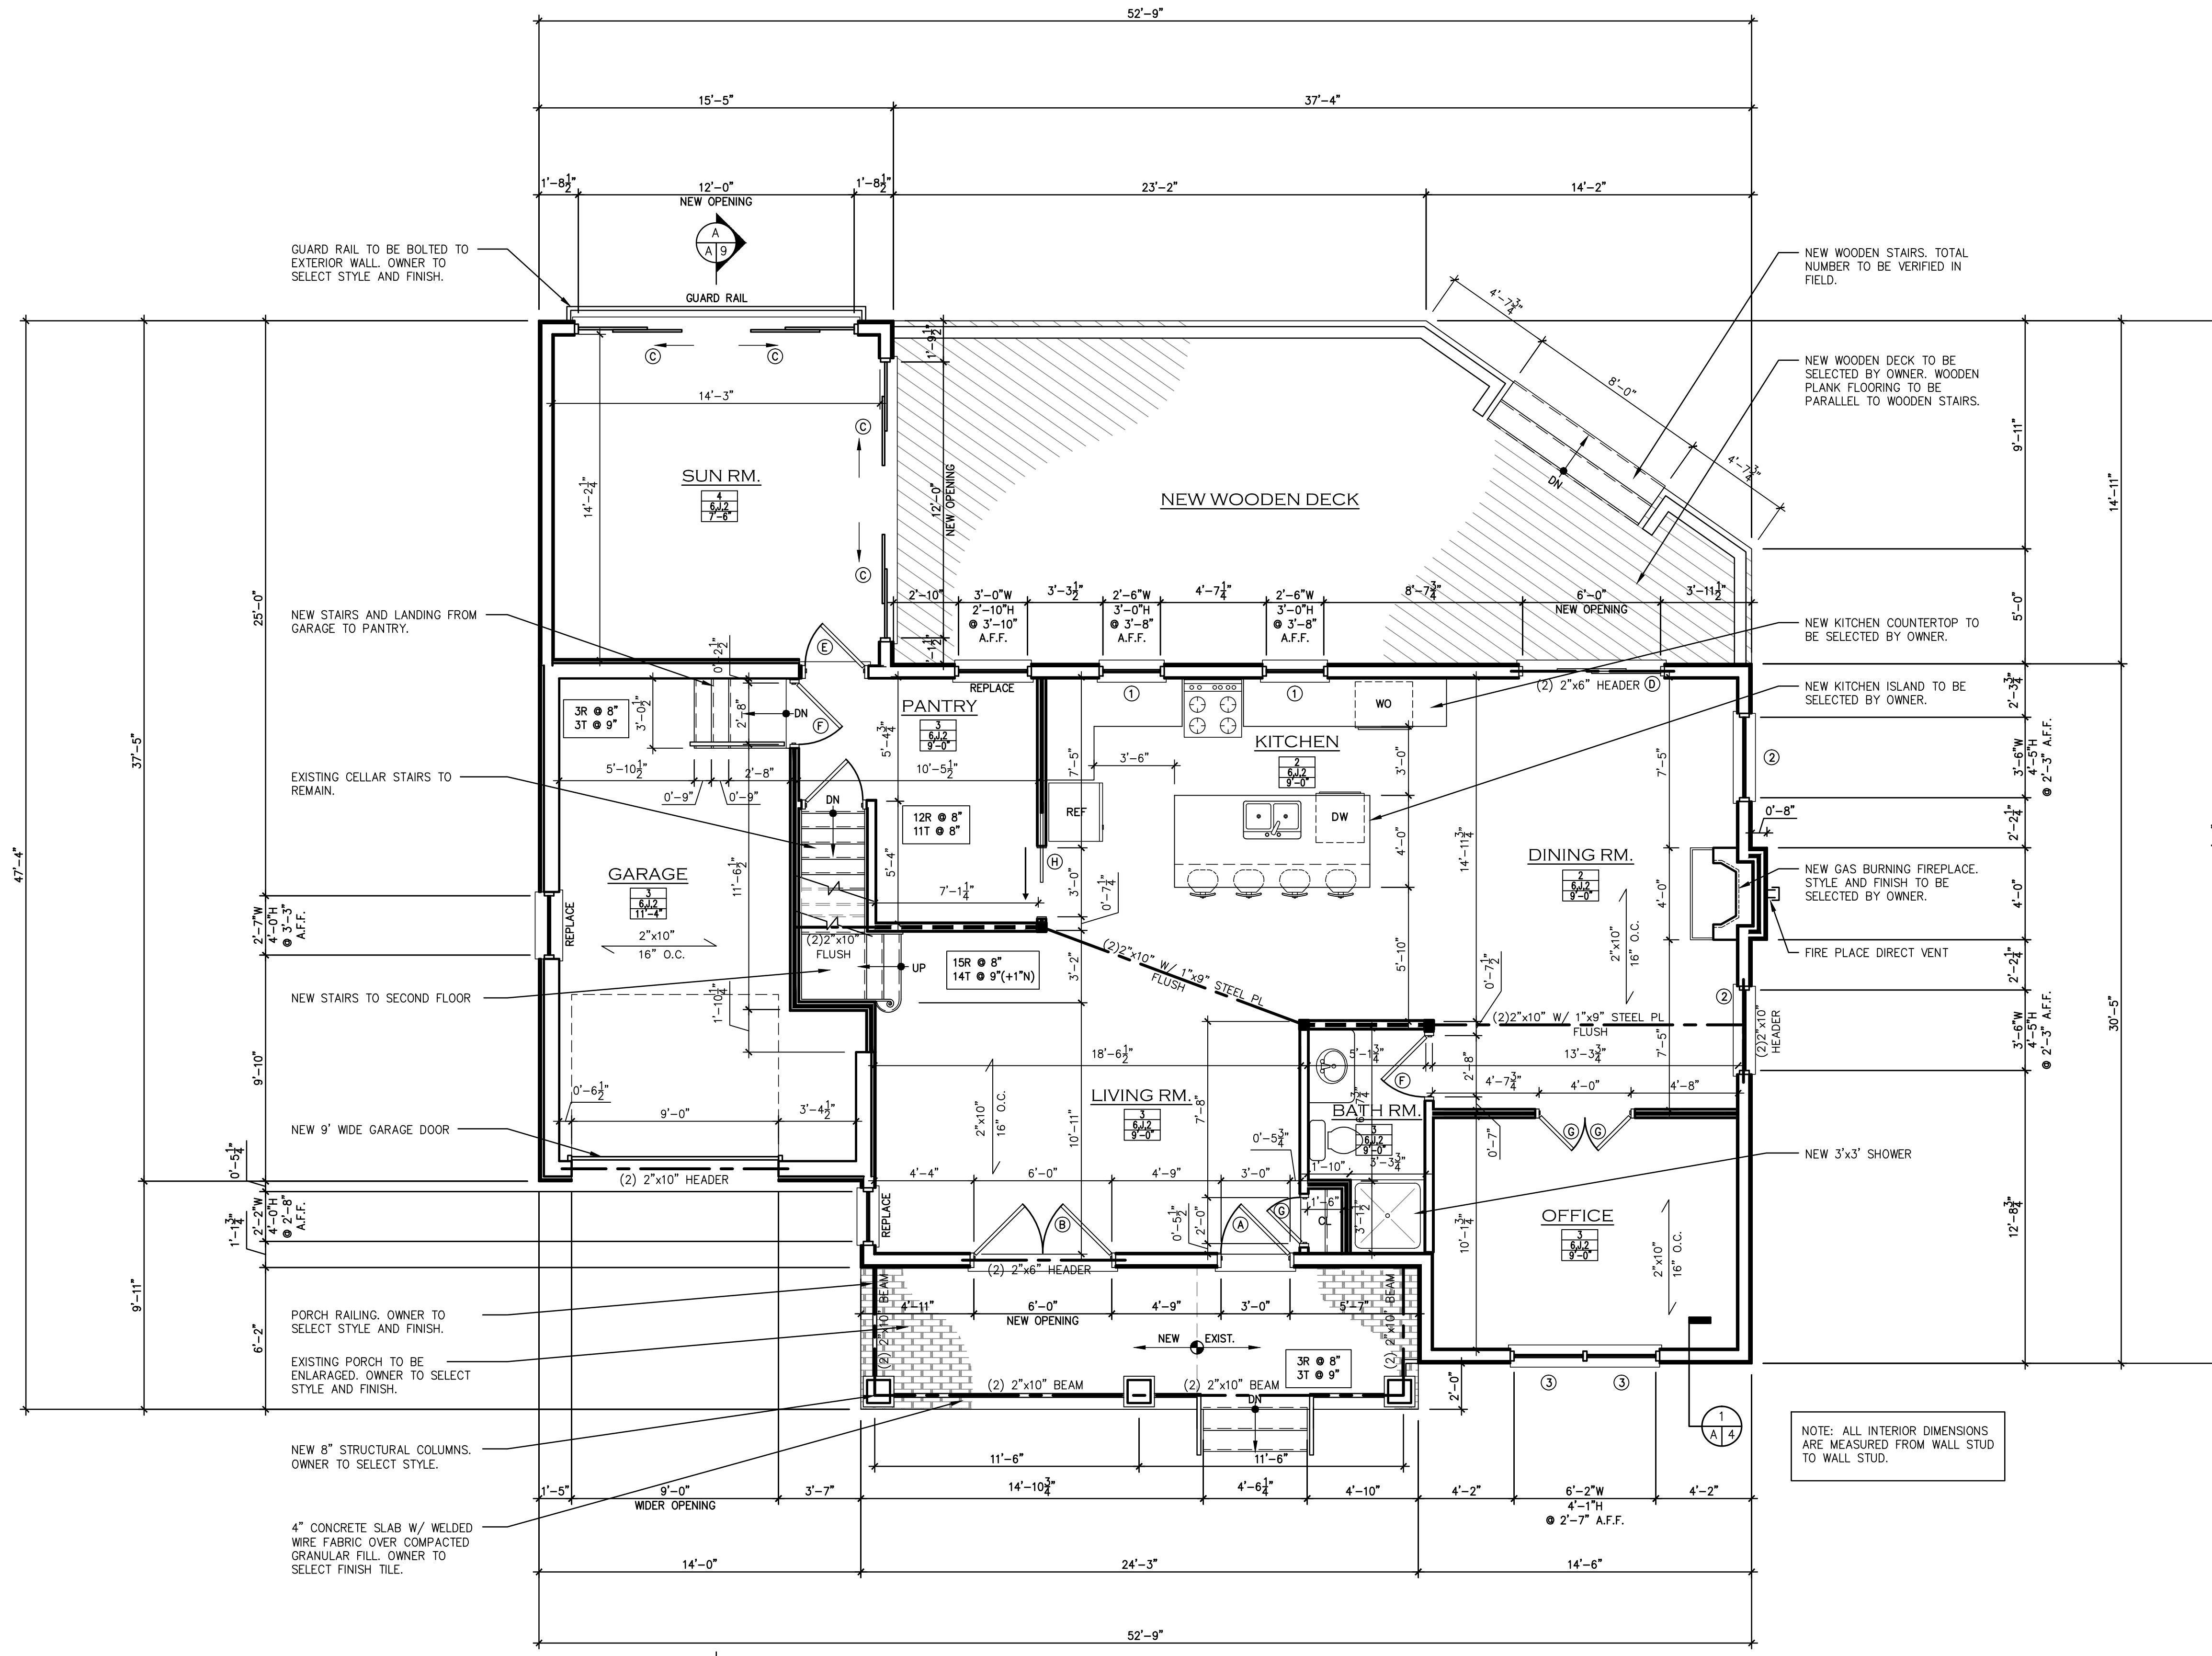

1ST FLOOR PLAN
SCALE: 1/4"=1'-0"

DETAIL 1
SCALE: 1/2"=1'-0"



T.F. CUSANELLI & FILLETTI
ARCHITECTS, P.C.

143 TERRACE STREET
HAWORTH, N.J. 07641
201-384-9595
N.J. R.A. LIC # 07976, 16378



PROPOSED:
SINGLE FAMILY RESIDENCE
353 TRENSCH SRIVE
NEW MILFORD, NJ 07646


REVISIONS		
NO.	DESCRIPTION	DATE

NO.	TO WHOM:	DATE

ISSUES	
DRAWN BY:	JOB NO.
AVM	2253NJ
CHECKED BY:	DATE:
VF	11/23/22


DWG. TITLE:
SECOND FLOOR PLAN

DWG. NO.
A-5

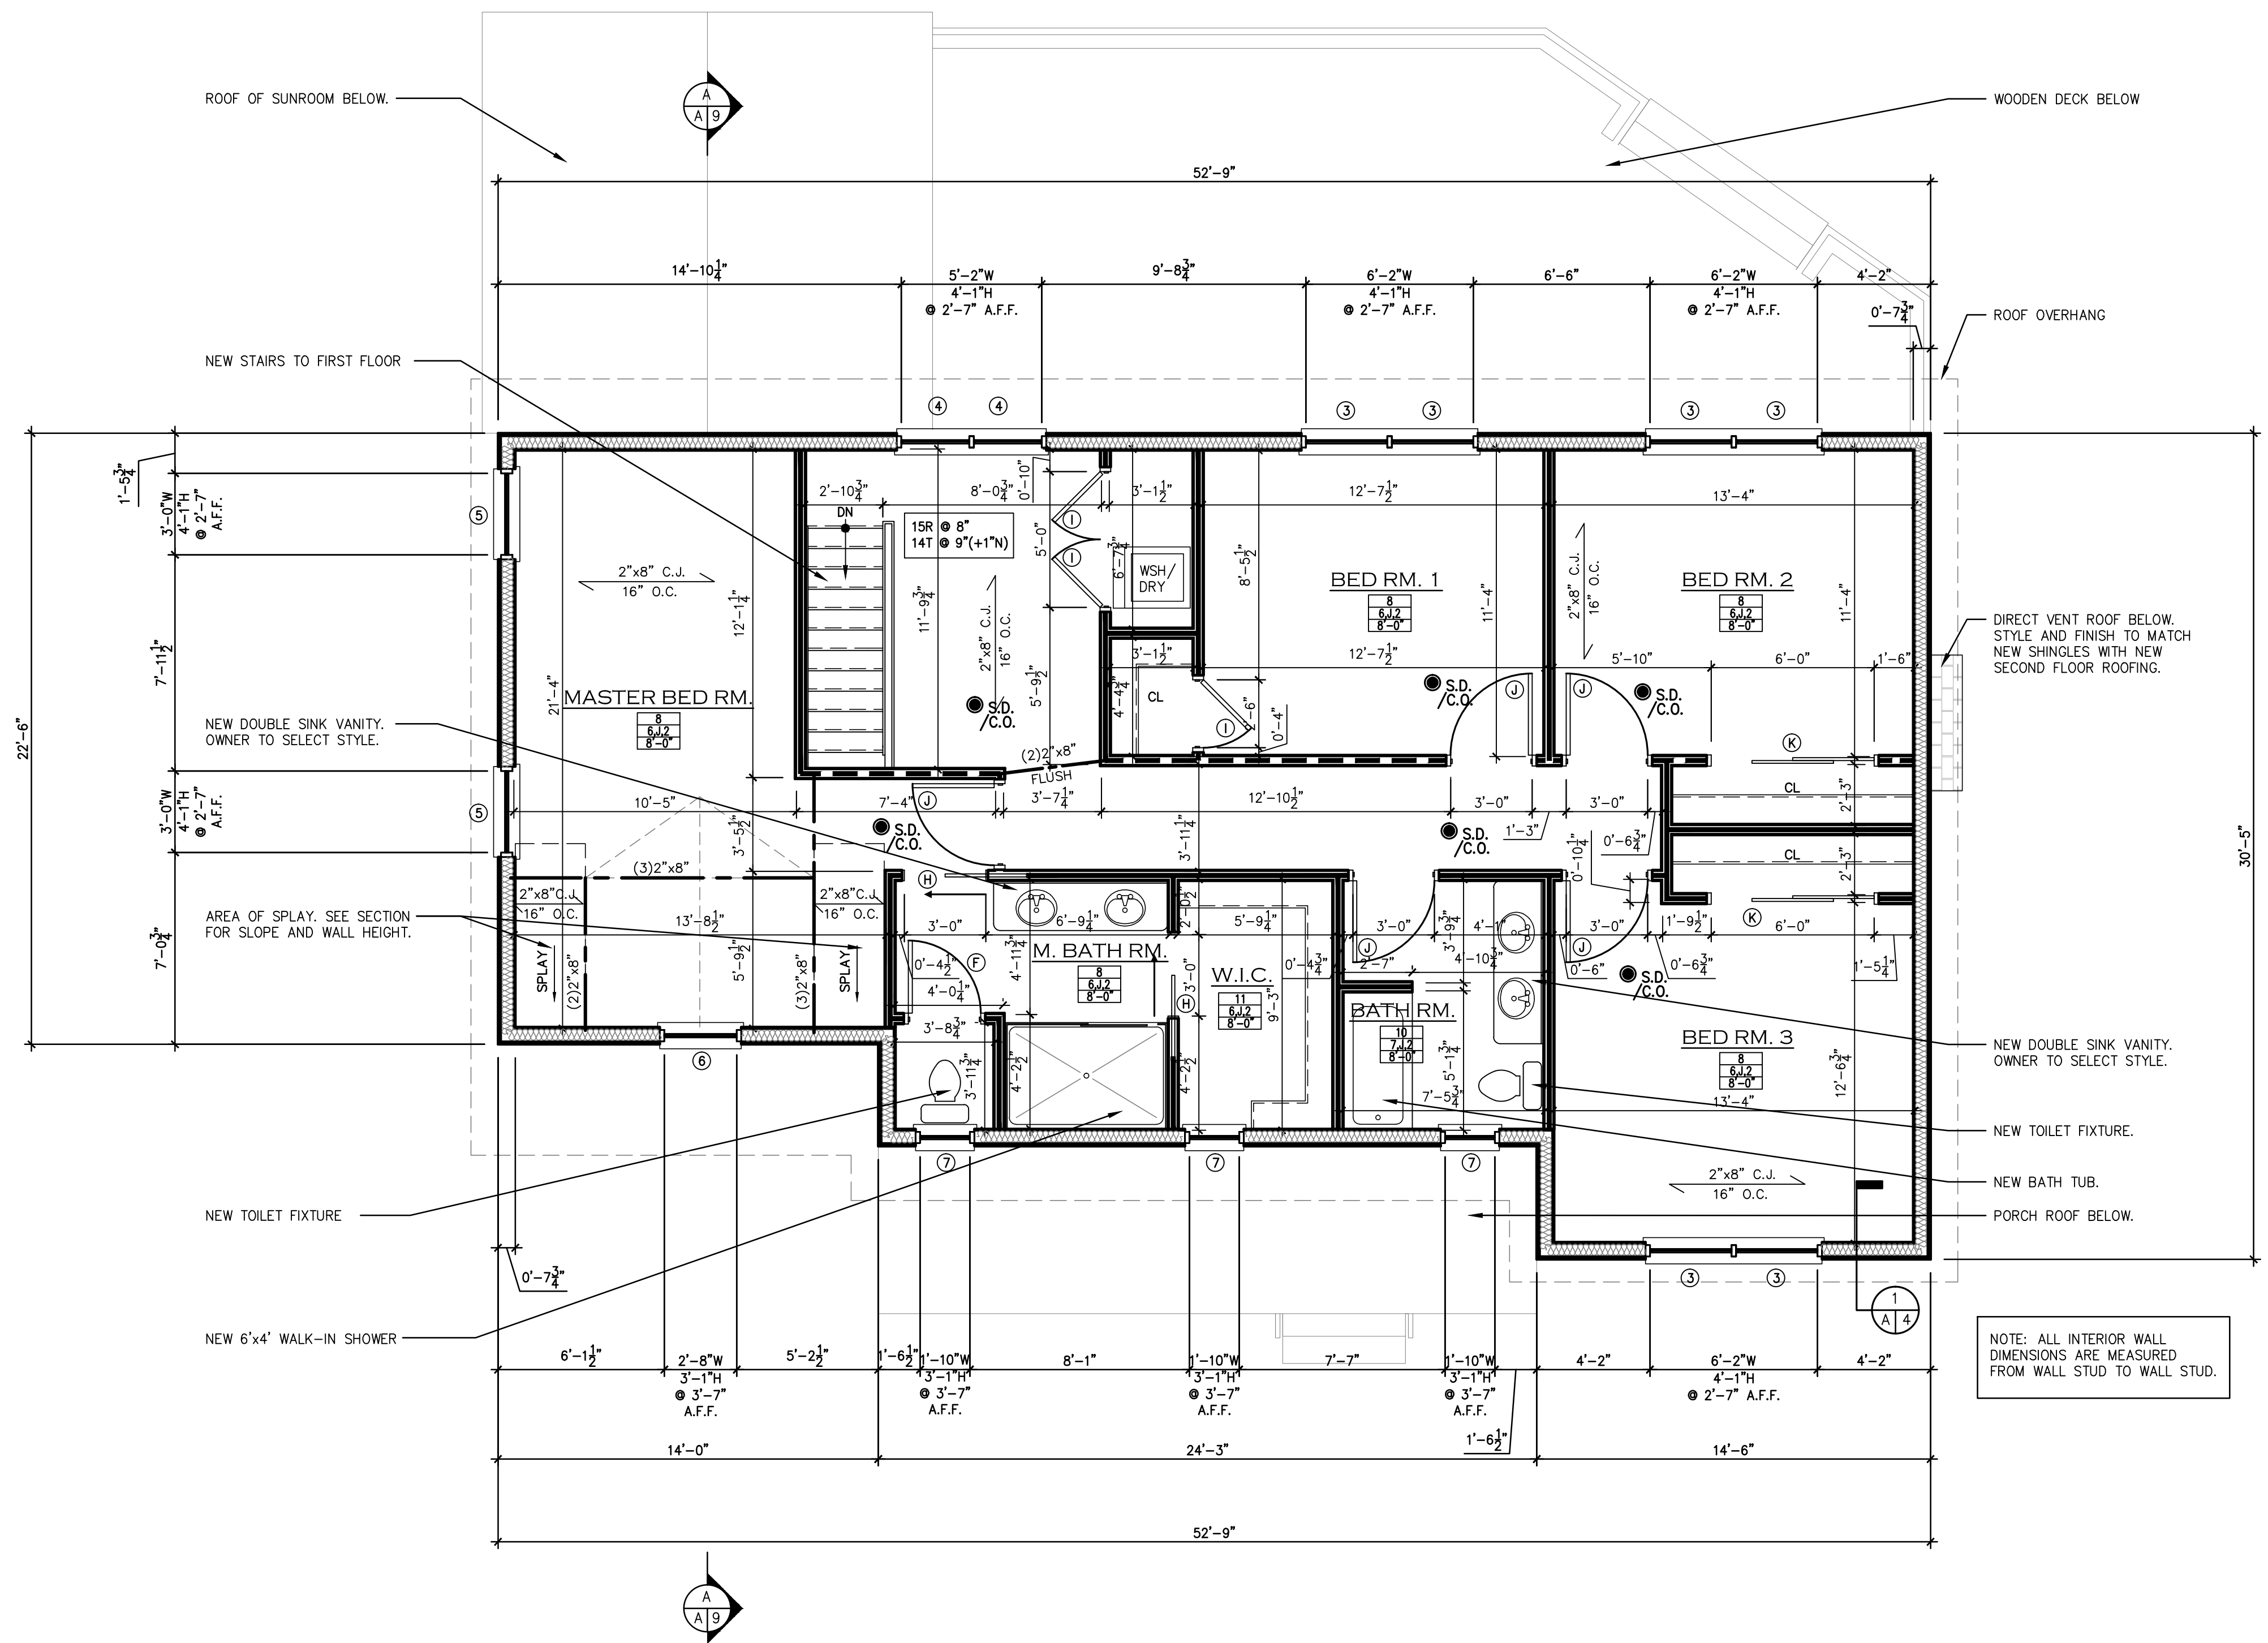


2ND FLOOR PLAN
SCALE: 1/4"=1'-0"

NOTE: ALL INTERIOR WALL DIMENSIONS ARE MEASURED FROM WALL STUD TO WALL STUD.

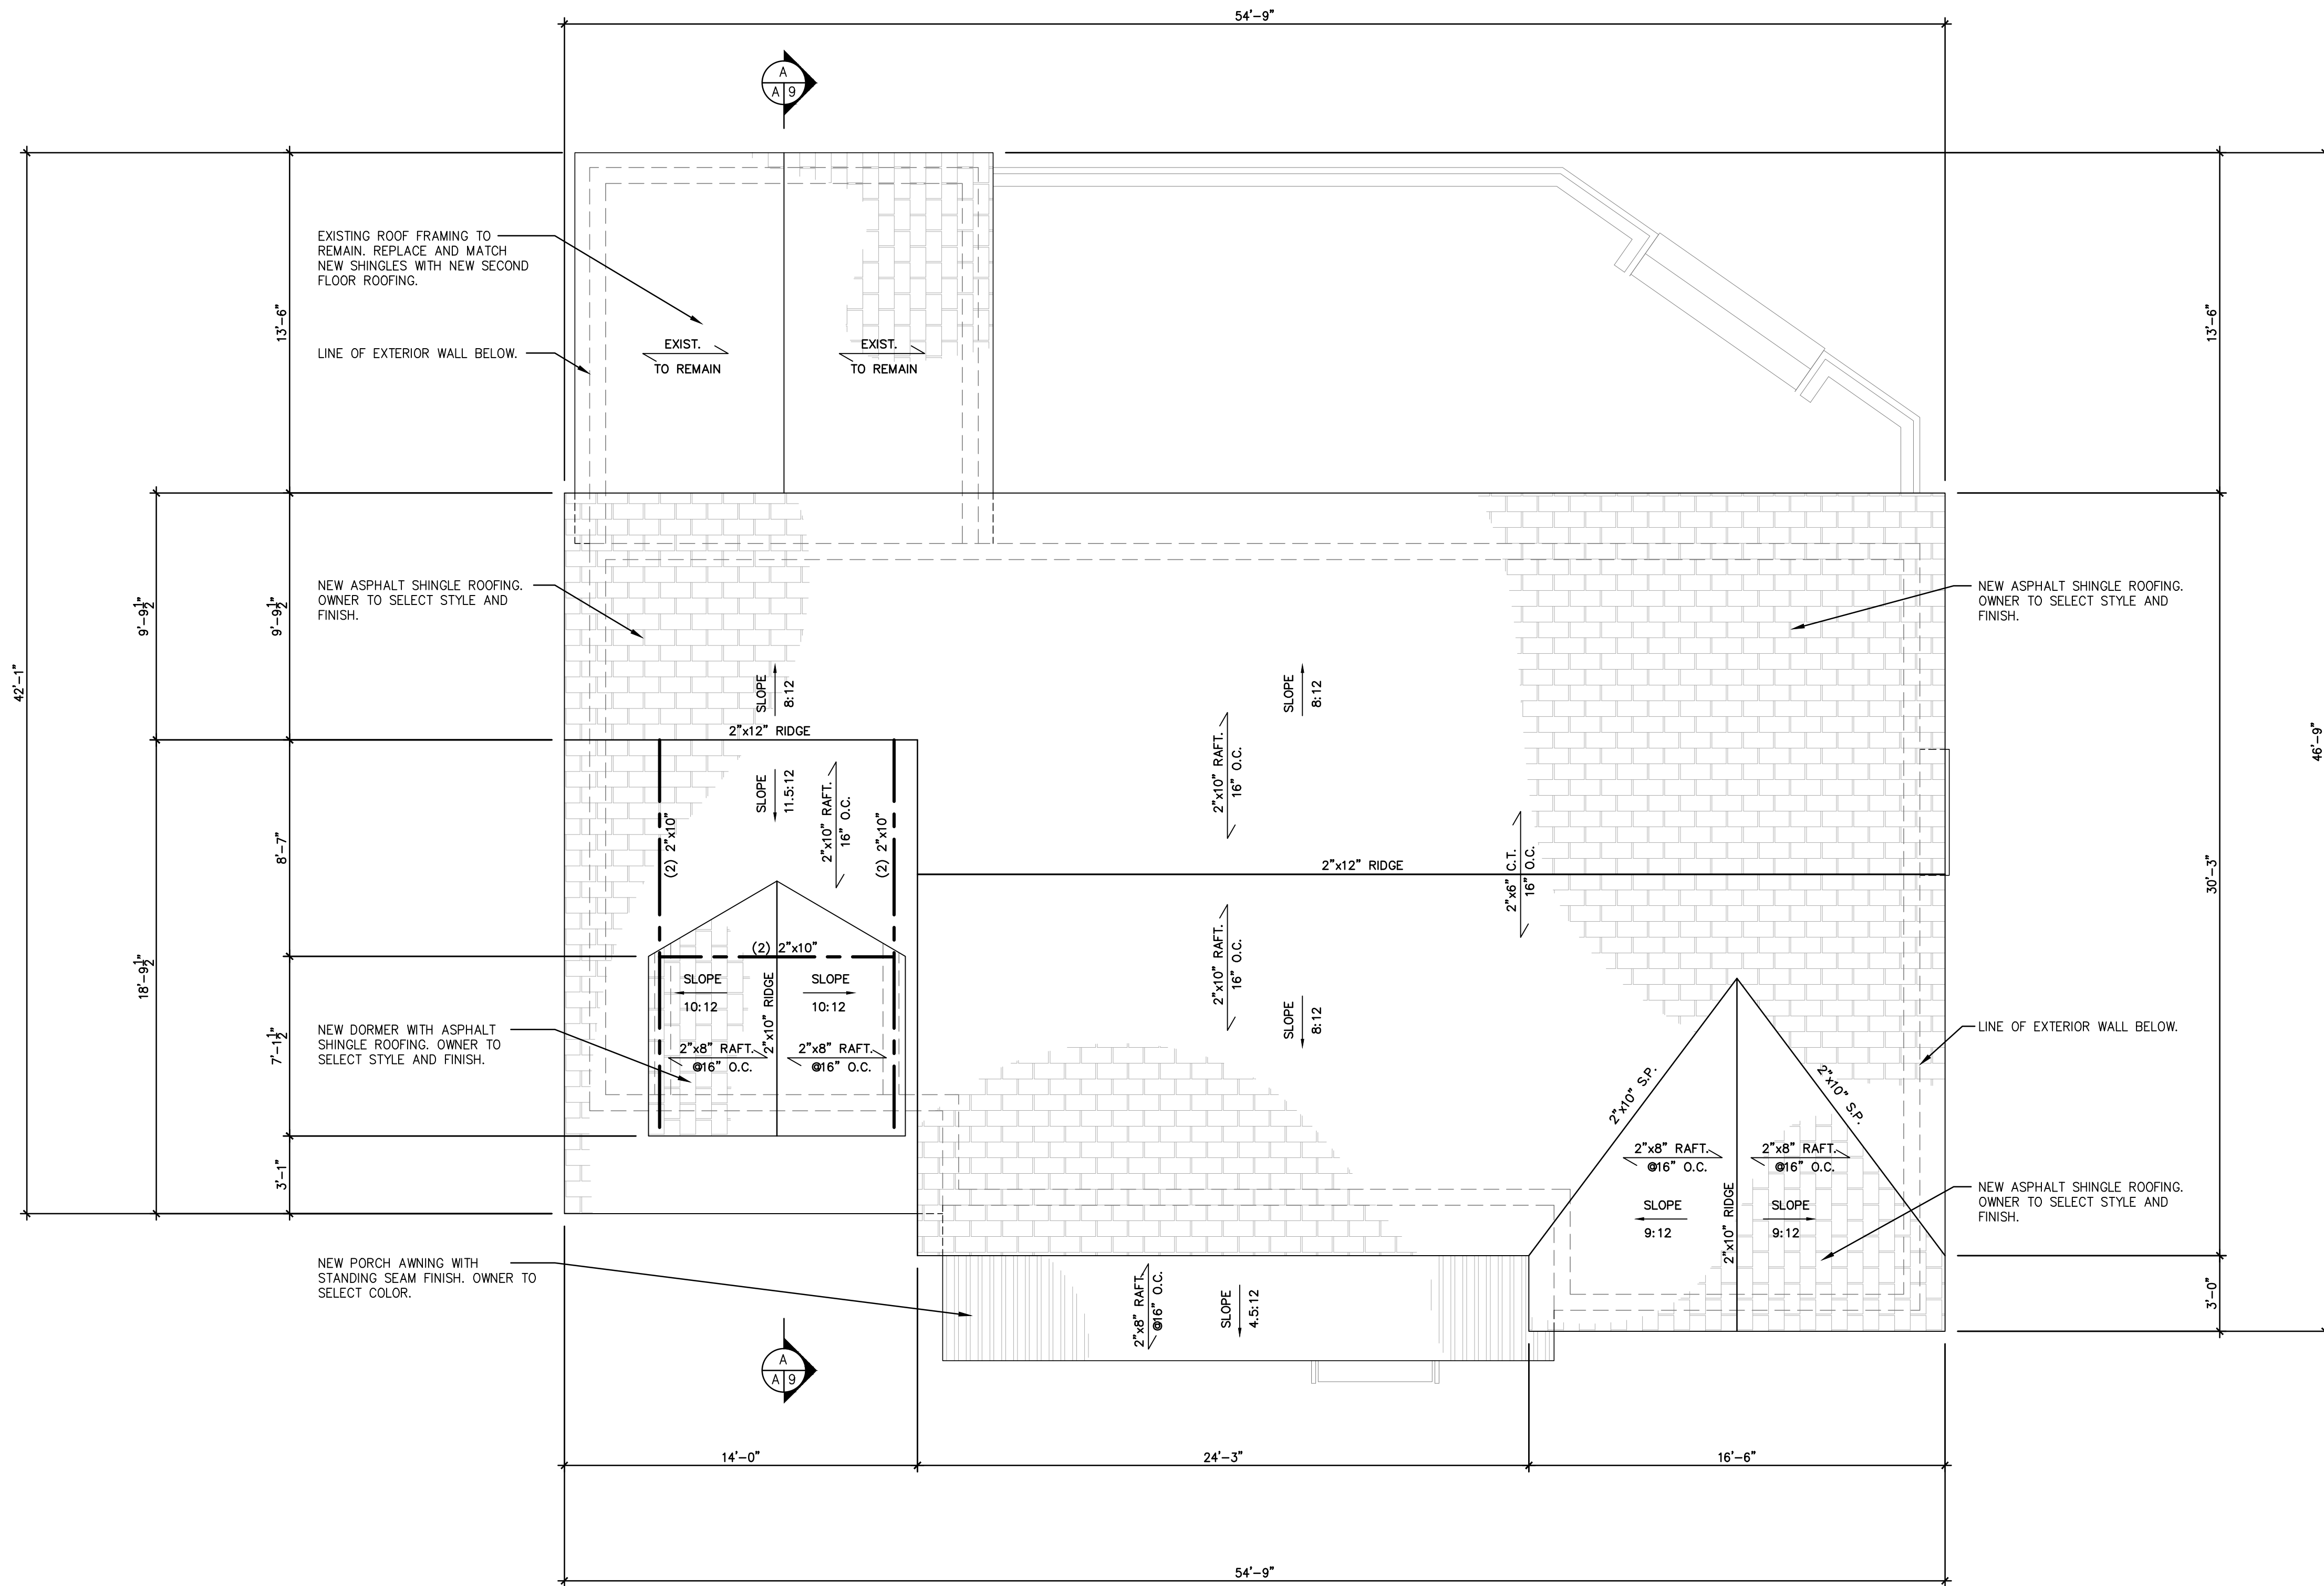

ROOF PLAN
SCALE: 1/4"=1'-0"

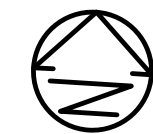

T.F. CUSANELLI & FILLETTI
ARCHITECTS, P.C.



PROPOSED :
SINGLE FAMILY RESIDENCE
353 TRENSCH SRIVE
NEW MILFORD, NJ 07646

REVISIONS		
NO.	DESCRIPTION	DATE

NO.	TO WHOM:	DATE

ISSUES	
DRAWN BY:	JOB NO.
AVM	2253NJ
CHECKED BY:	DATE:
VF	11/23/22

DWG. TITLE :
ROOF PLAN

DWG. NO.
A-6



T.F. CUSANELLI & FILLETTI
ARCHITECTS, P.C.
143 TERRACE STREET
HAWORTH, N.J. 07641
201-384-9595
N.J. R.A. LIC # 07976, 16378



PROPOSED:
SINGLE FAMILY RESIDENCE
353 TRENSCH SRIVE
NEW MILFORD, NJ 07646

REVISIONS		
NO.	DESCRIPTION	DATE

NO.	TO WHOM:	DATE

ISSUES	
DRAWN BY:	JOB NO.
AVM	2253NJ
CHECKED BY:	DATE:
VF	11/23/22


DWG. TITLE:
FRONT AND
RIGHT
ELEVATIONS

DWG. NO.
A-7



FRONT ELEVATION

SCALE: 1/4"=1'-0"

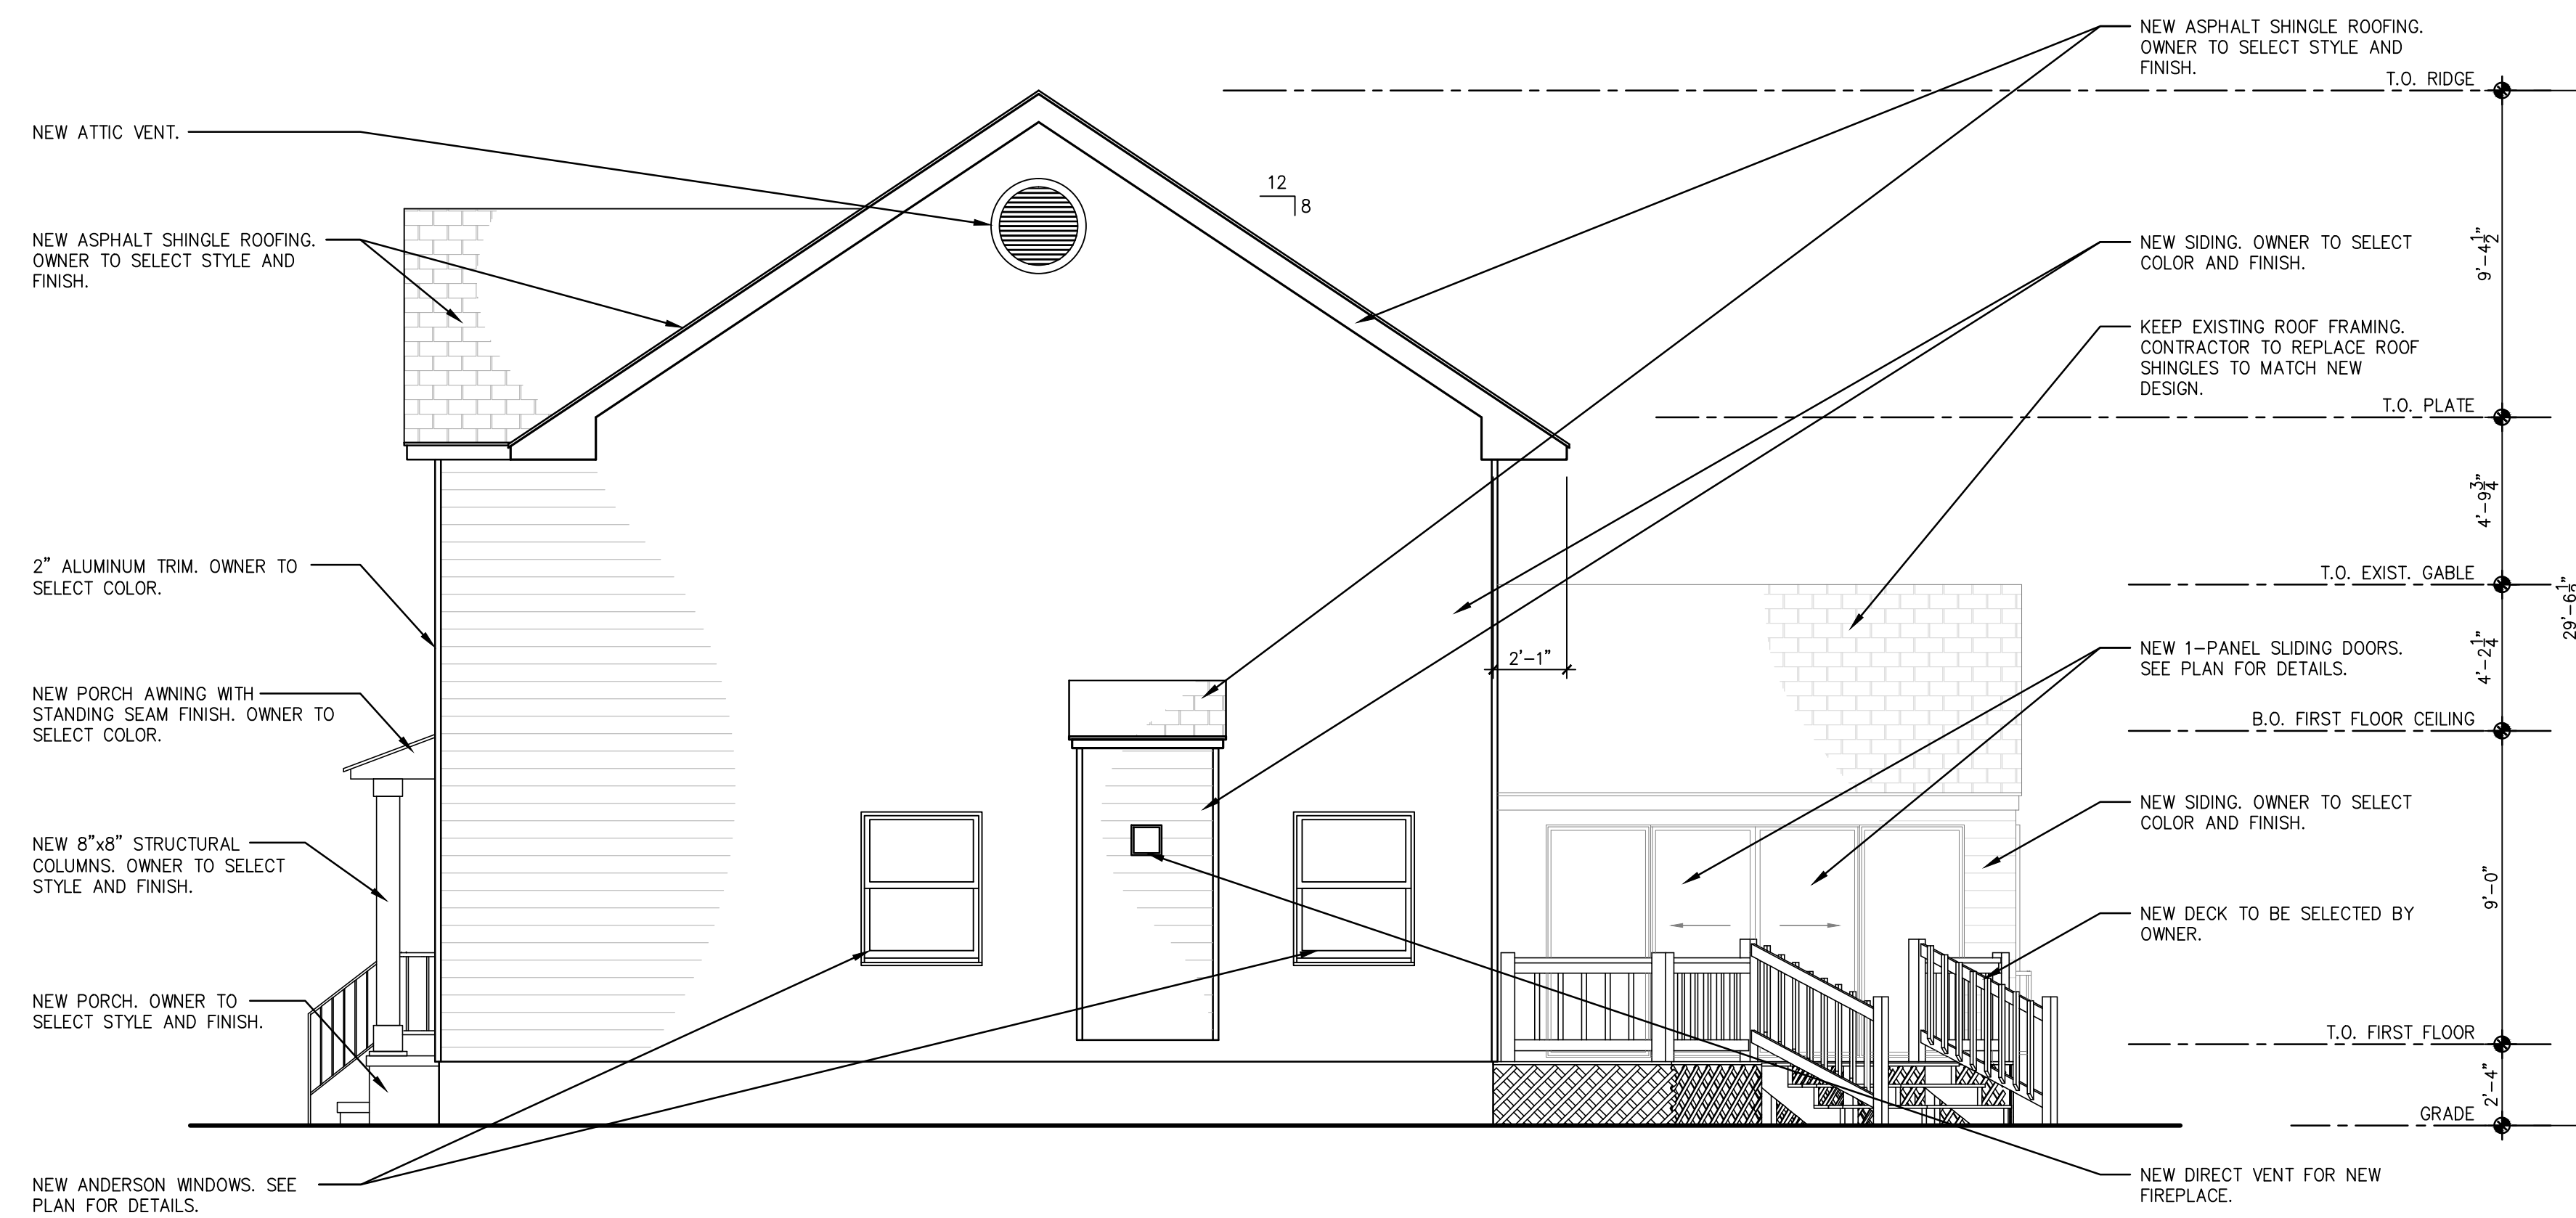

RIGHT ELEVATION

SCALE: 1/4"=1'-0"



T.F. CUSANELLI & FILLETTI
ARCHITECTS, P.C.
143 TERRACE STREET
HAWORTH, N.J. 07641
201-384-9595
N.J. R.A. LIC # 07976, 16378




PROPOSED:
SINGLE FAMILY RESIDENCE
353 TRENSCH DRIVE
NEW MILFORD, NJ 07646



REAR ELEVATION

SCALE: 1/4"=1'-0"

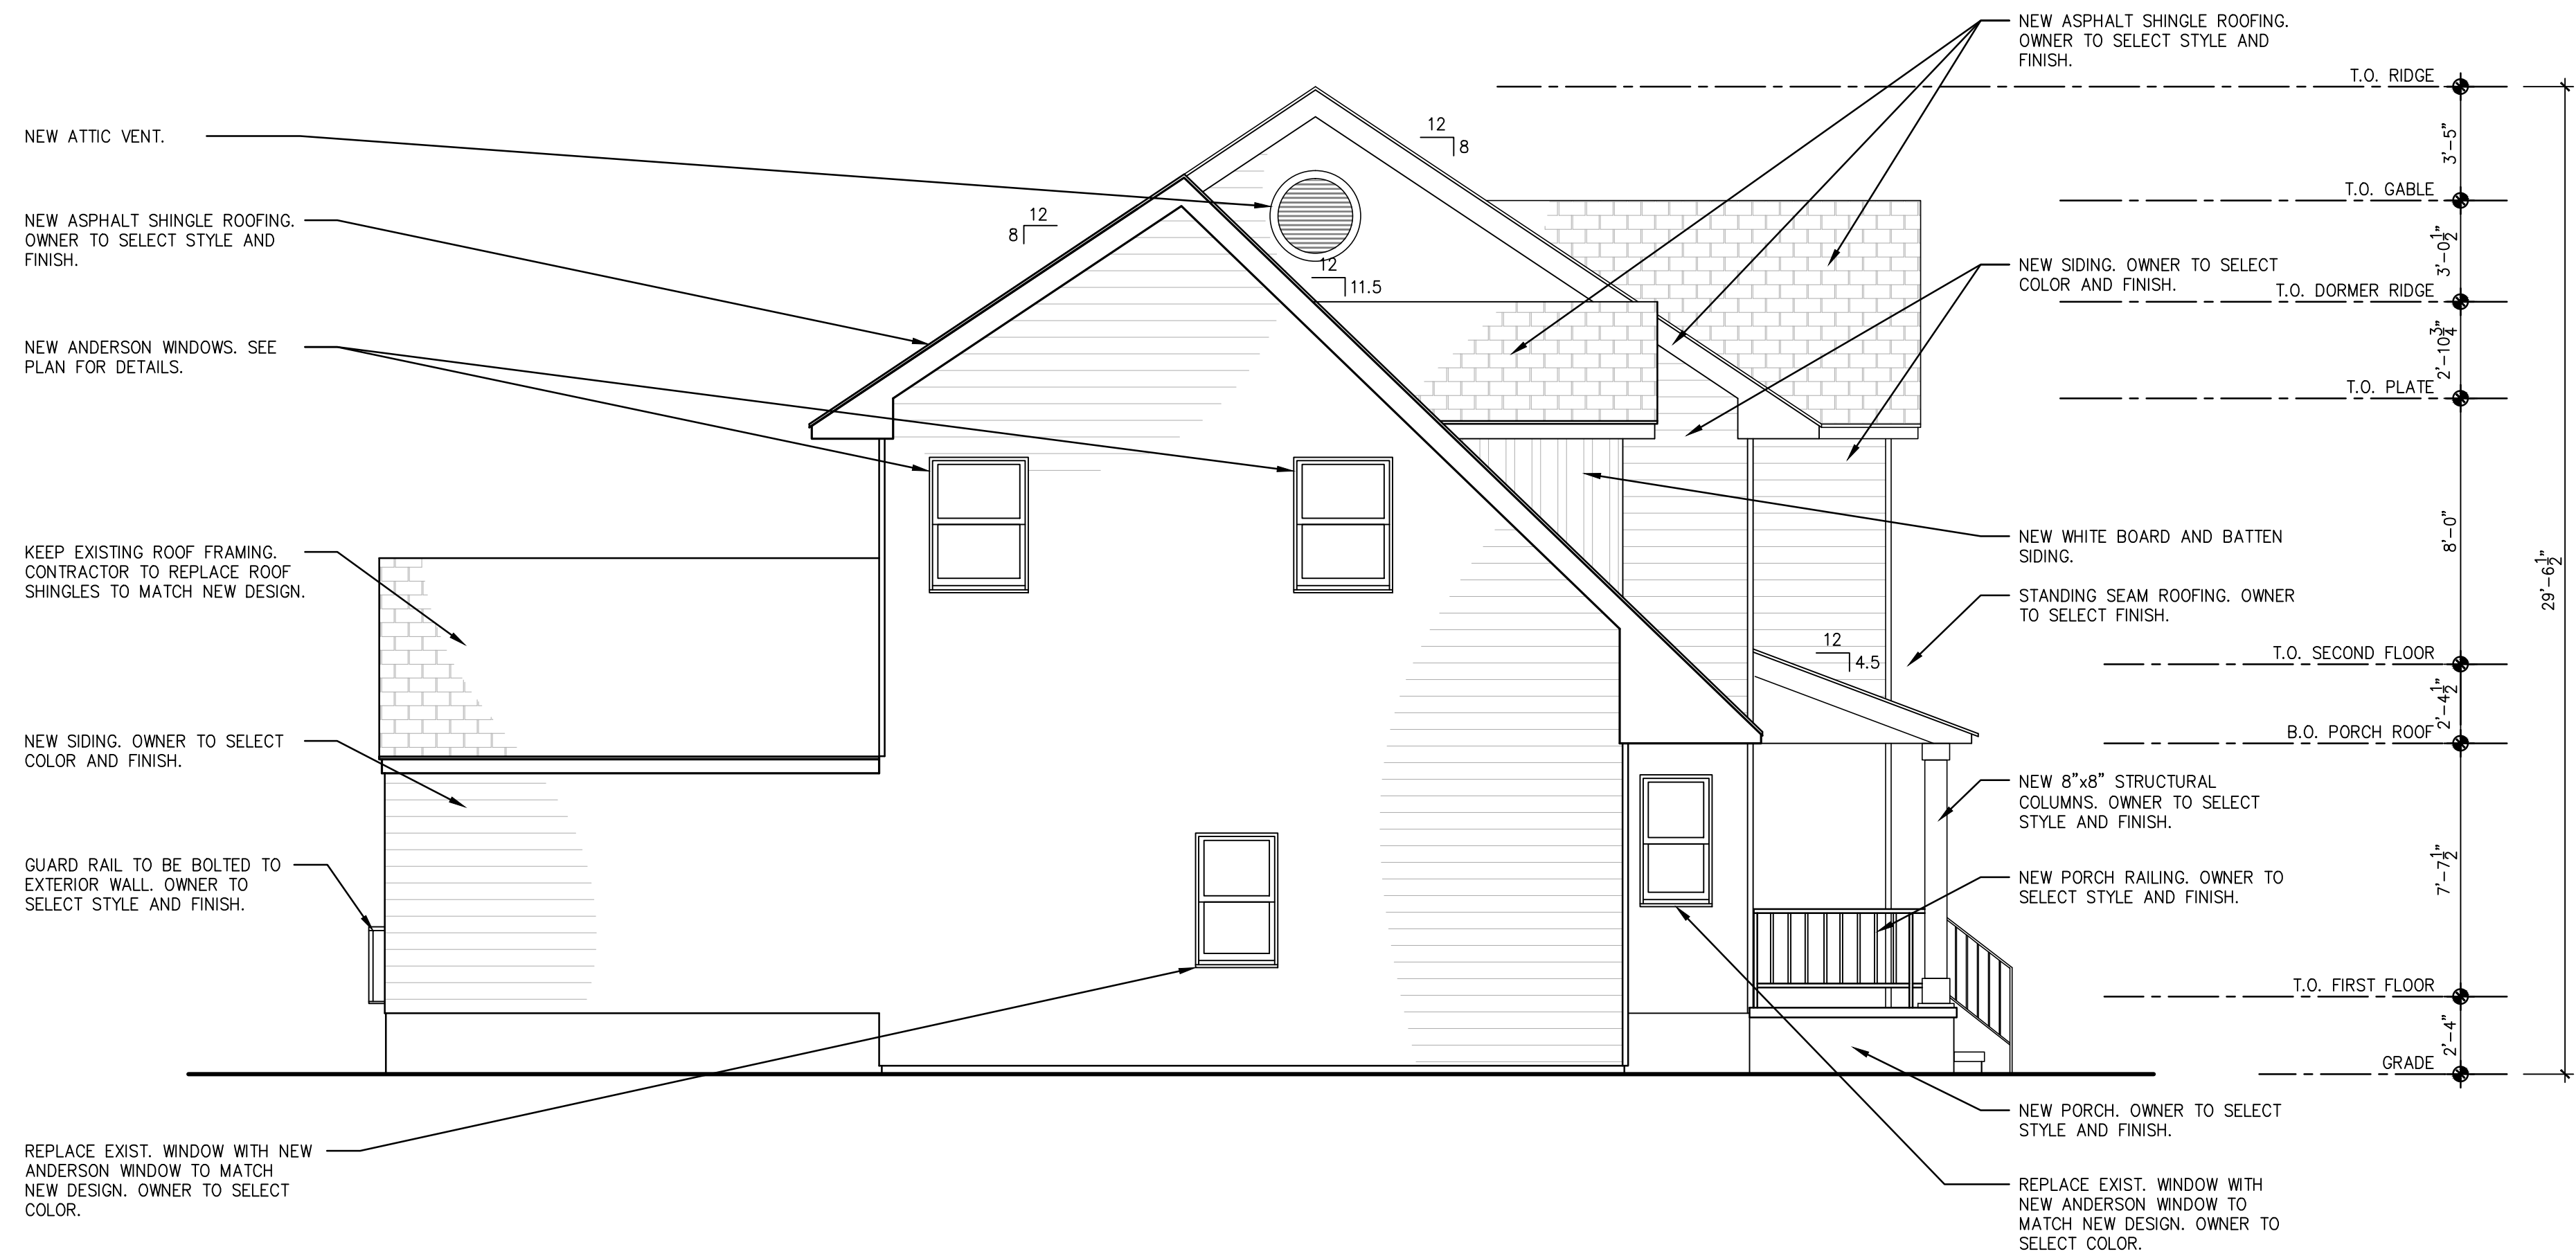

LEFT ELEVATION

SCALE: 1/4"=1'-0"

REVISIONS		
NO.	DESCRIPTION	DATE

NO.	TO WHOM	DATE

ISSUES	
DRAWN BY:	JOB NO.
AVM	2253NJ
CHECKED BY:	DATE:
VF	11/23/22

DWG. TITLE:
REAR AND LEFT ELEVATIONS

DWG. NO.
A-8



T.F. CUSANELLI & FILLETTI
ARCHITECTS, P.C.



PROPOSED:
SINGLE FAMILY RESIDENCE
353 TRENSCH SRIVE
NEW MILFORD, NJ 07646


REVISIONS		
NO.	DESCRIPTION	DATE

NO.	TO WHOM	DATE

ISSUES	
DRAWN BY:	JOB NO.
AVM	2253NJ
CHECKED BY:	DATE:
VF	11/23/22


DWG. TITLE:
BUILDING SECTION,
RISER DIAGRAMS

DWG. NO.
A-9

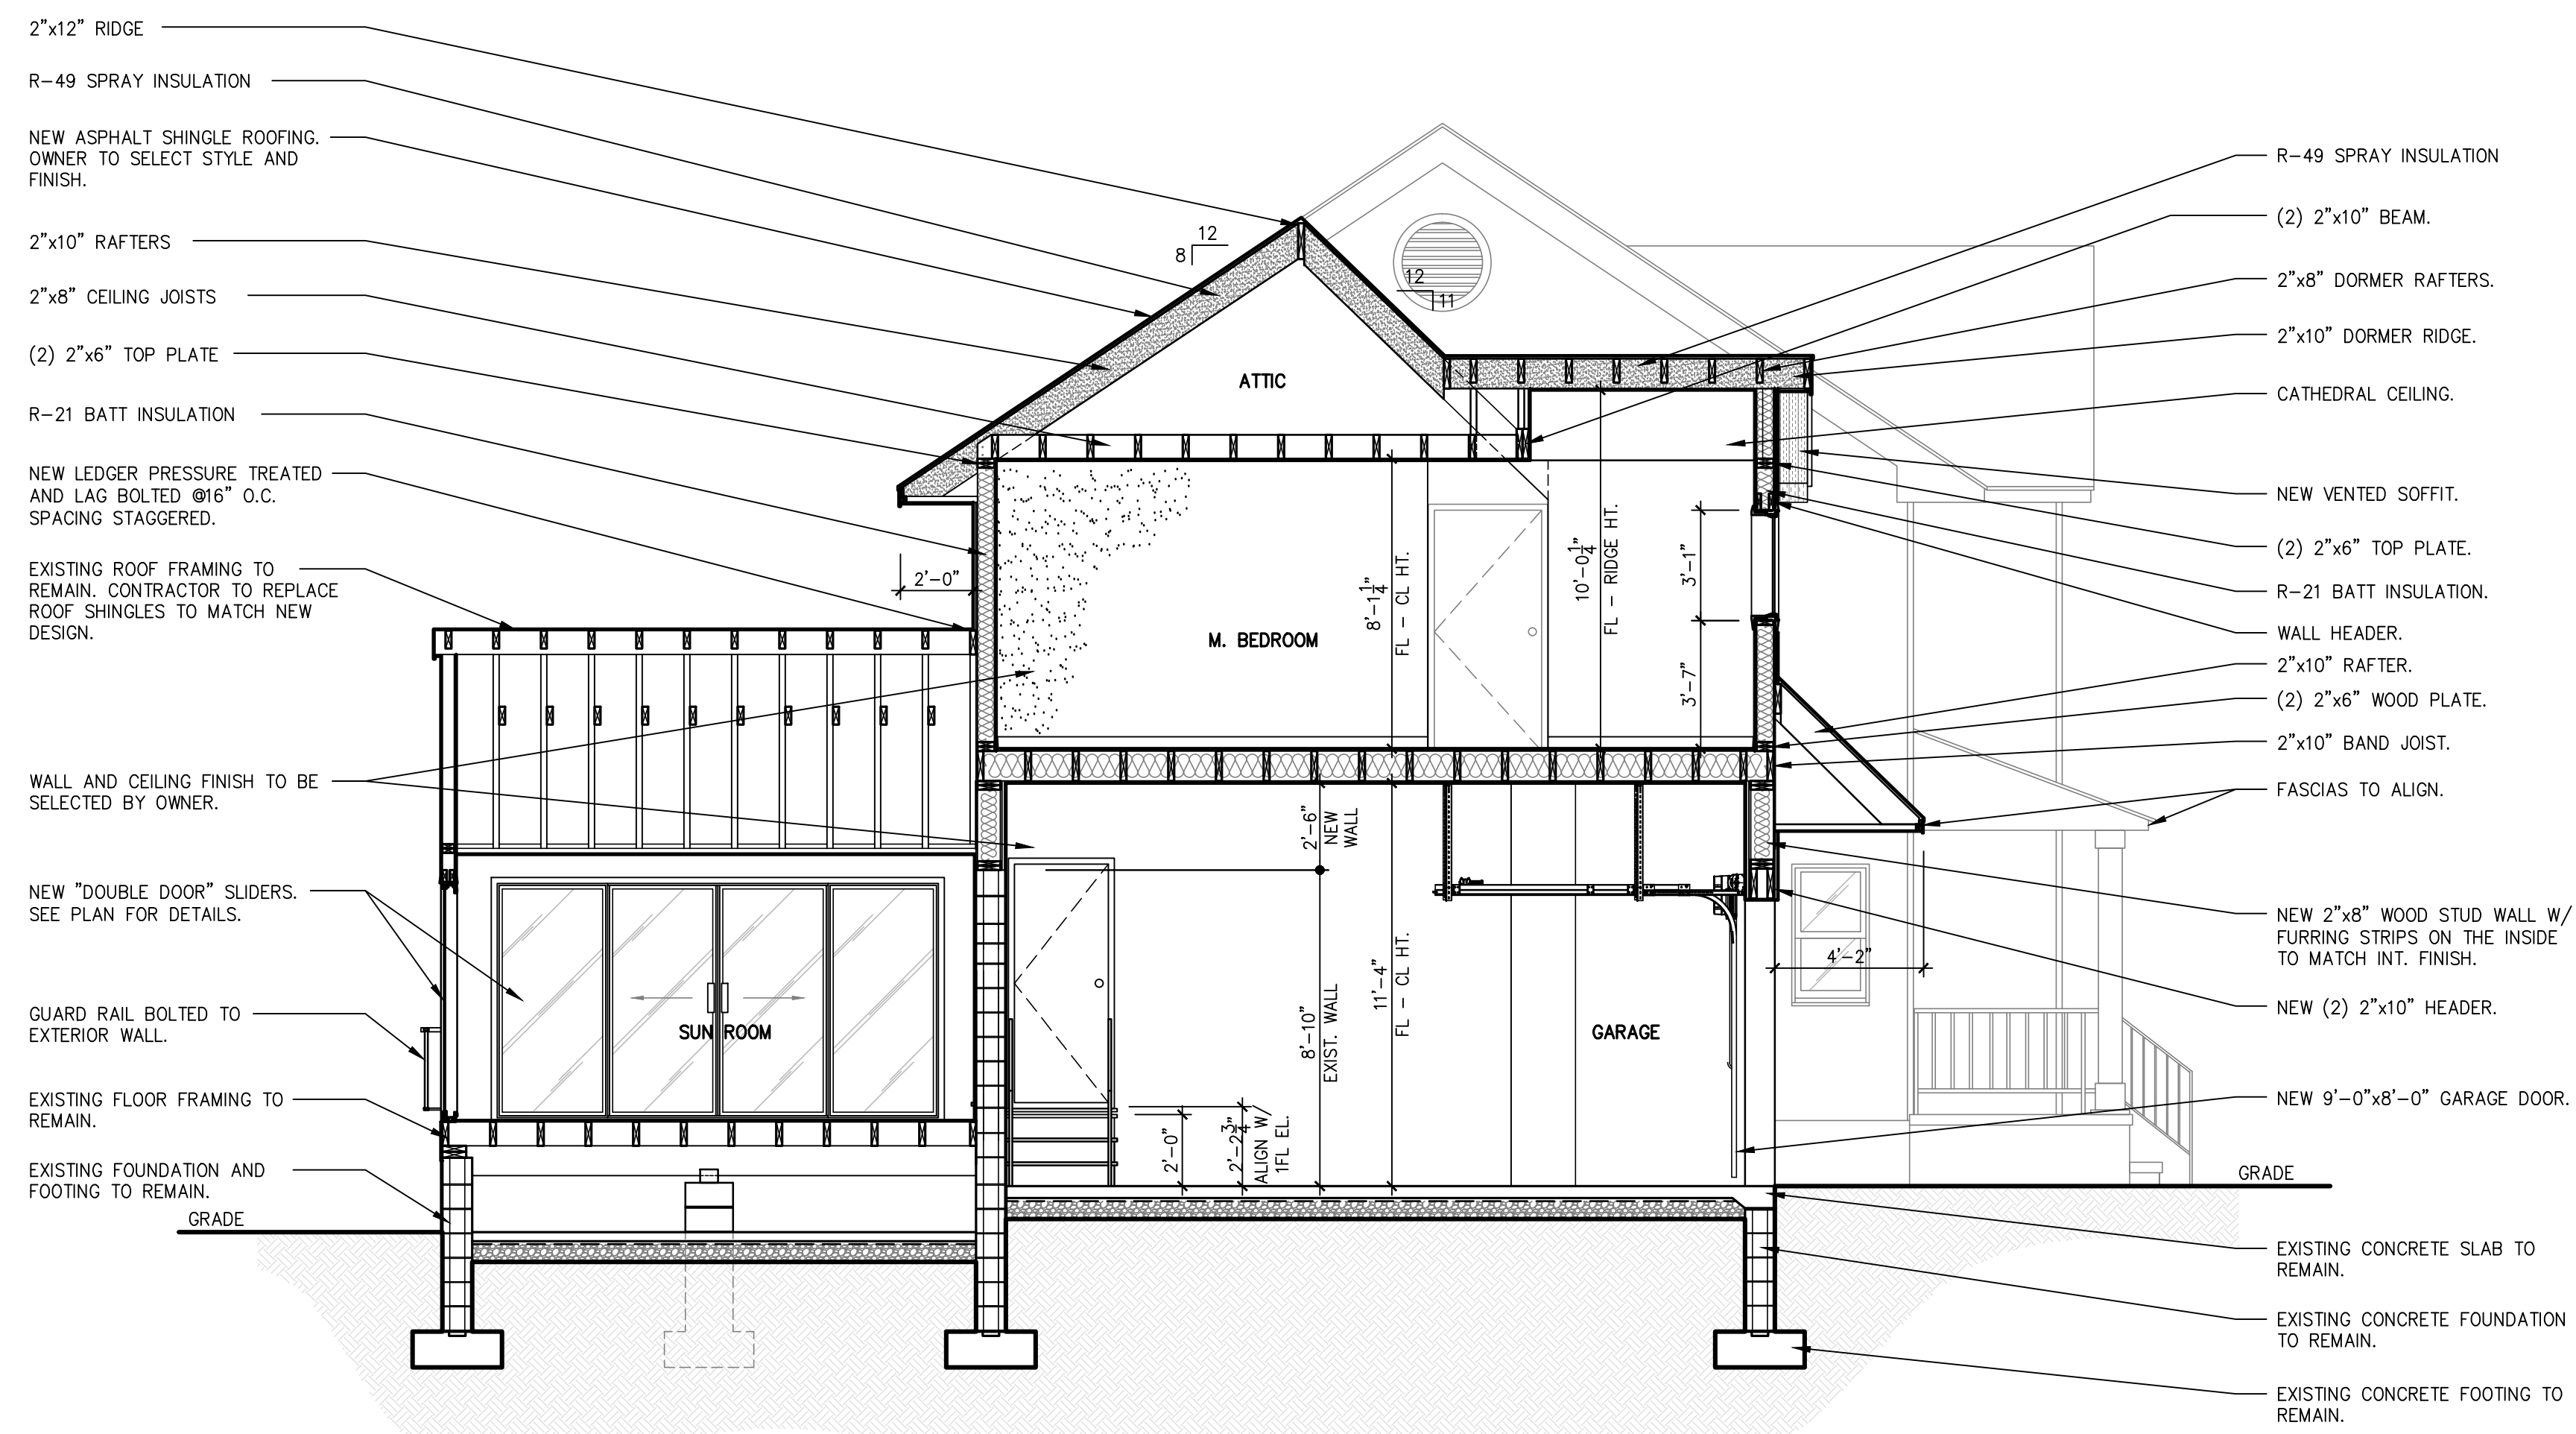


SECTION A-A

SCALE: 1/4"=1'-0"

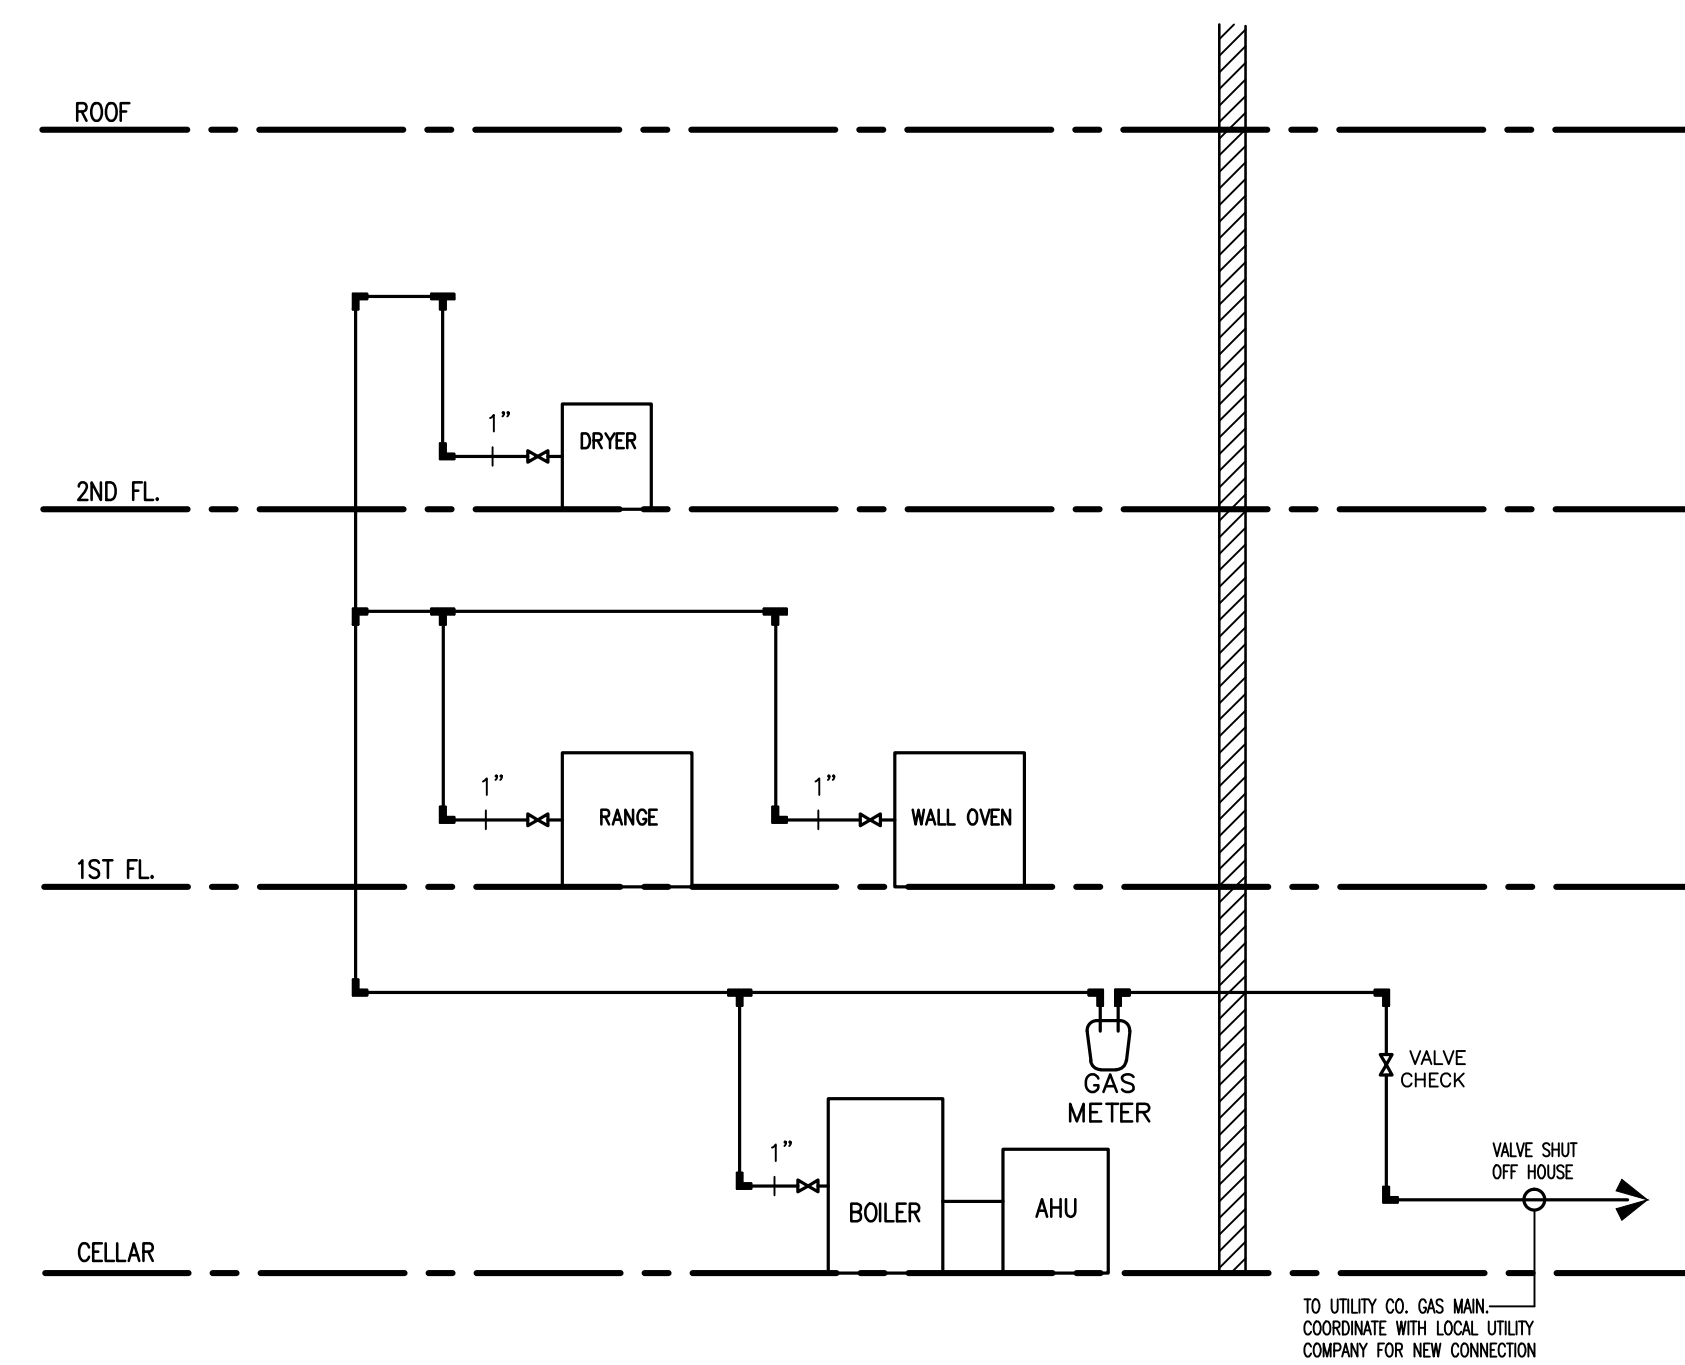

GAS RISER DIAGRAM

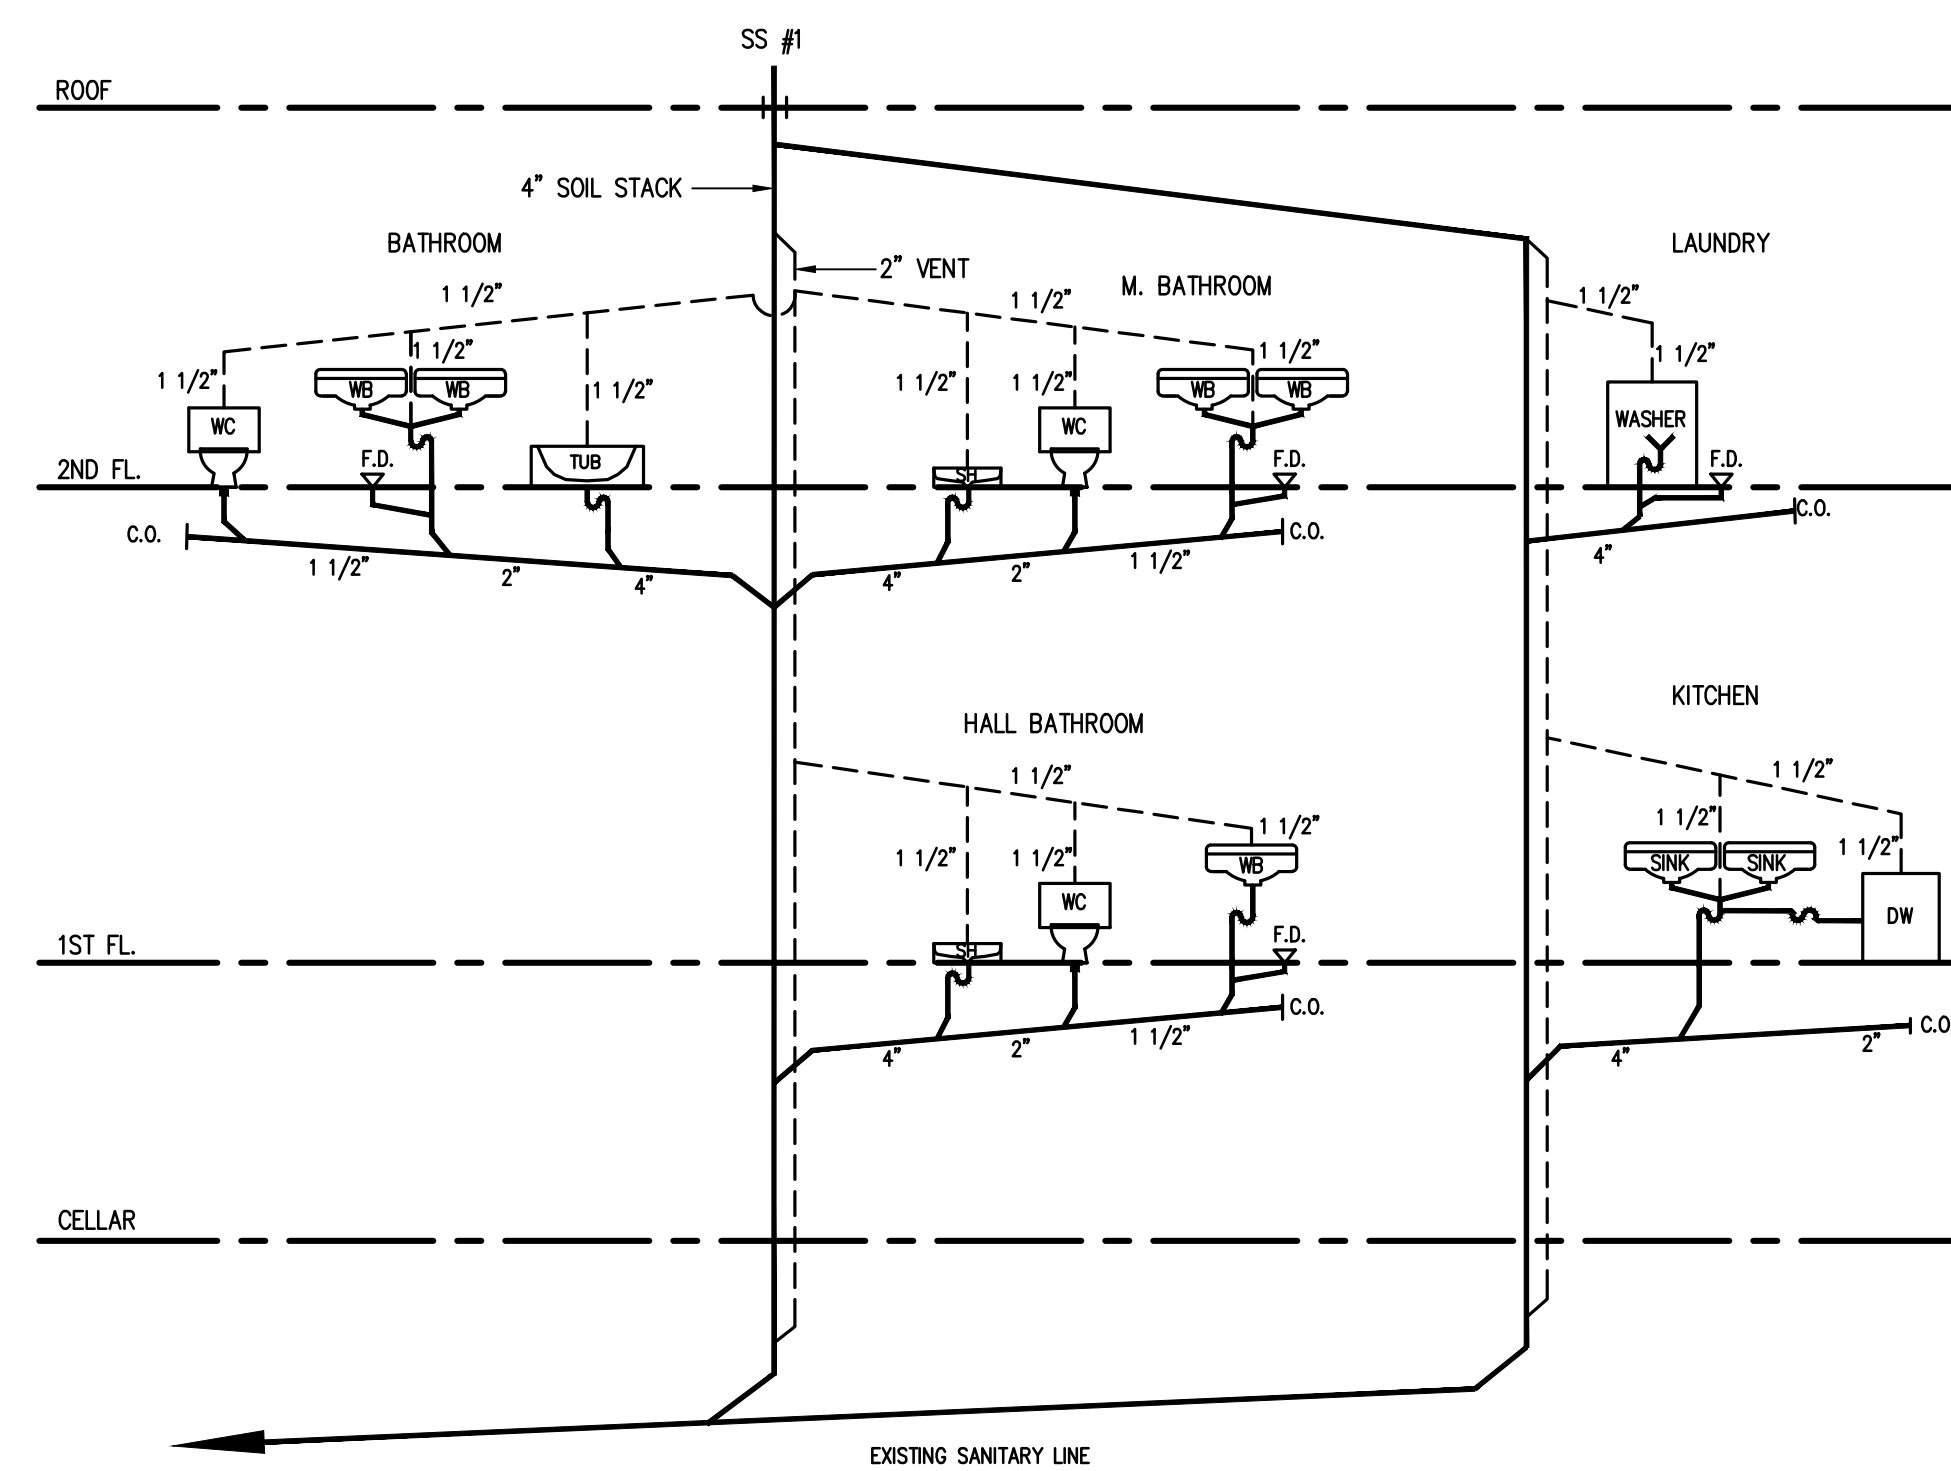

PLUMBING RISER DIAGRAM